

A d d e n d u m

Iowa Department of Transportation
Office of Contracts

Date of Letting: June 16, 2015
Date of Addendum: June 11, 2015

B.O.	Proposal ID	Proposal Work Type	County	Project Number	Addendum
358	79-0634-050	LIGHTING	Poweshiek	NHSN-063-4(50)--2R-79	16JUN358.A01

Make the following changes to the PROPOSAL SCHEDULE OF PRICES:

Change Proposal Line No. 0010 2523-0000200 ELECTRICAL CIRCUITS:

From: 986.000 LF

To: 1,496.000 LF


Change Proposal Line No. 0020 2523-0000310 HANDHOLES AND JUCTION BOXES:

From: 9.000 EACH

To: 12.000 EACH


If the above change is not made, it will be made as shown here.

Replace plan Sheet: P.1 with the attached Plan Sheets:

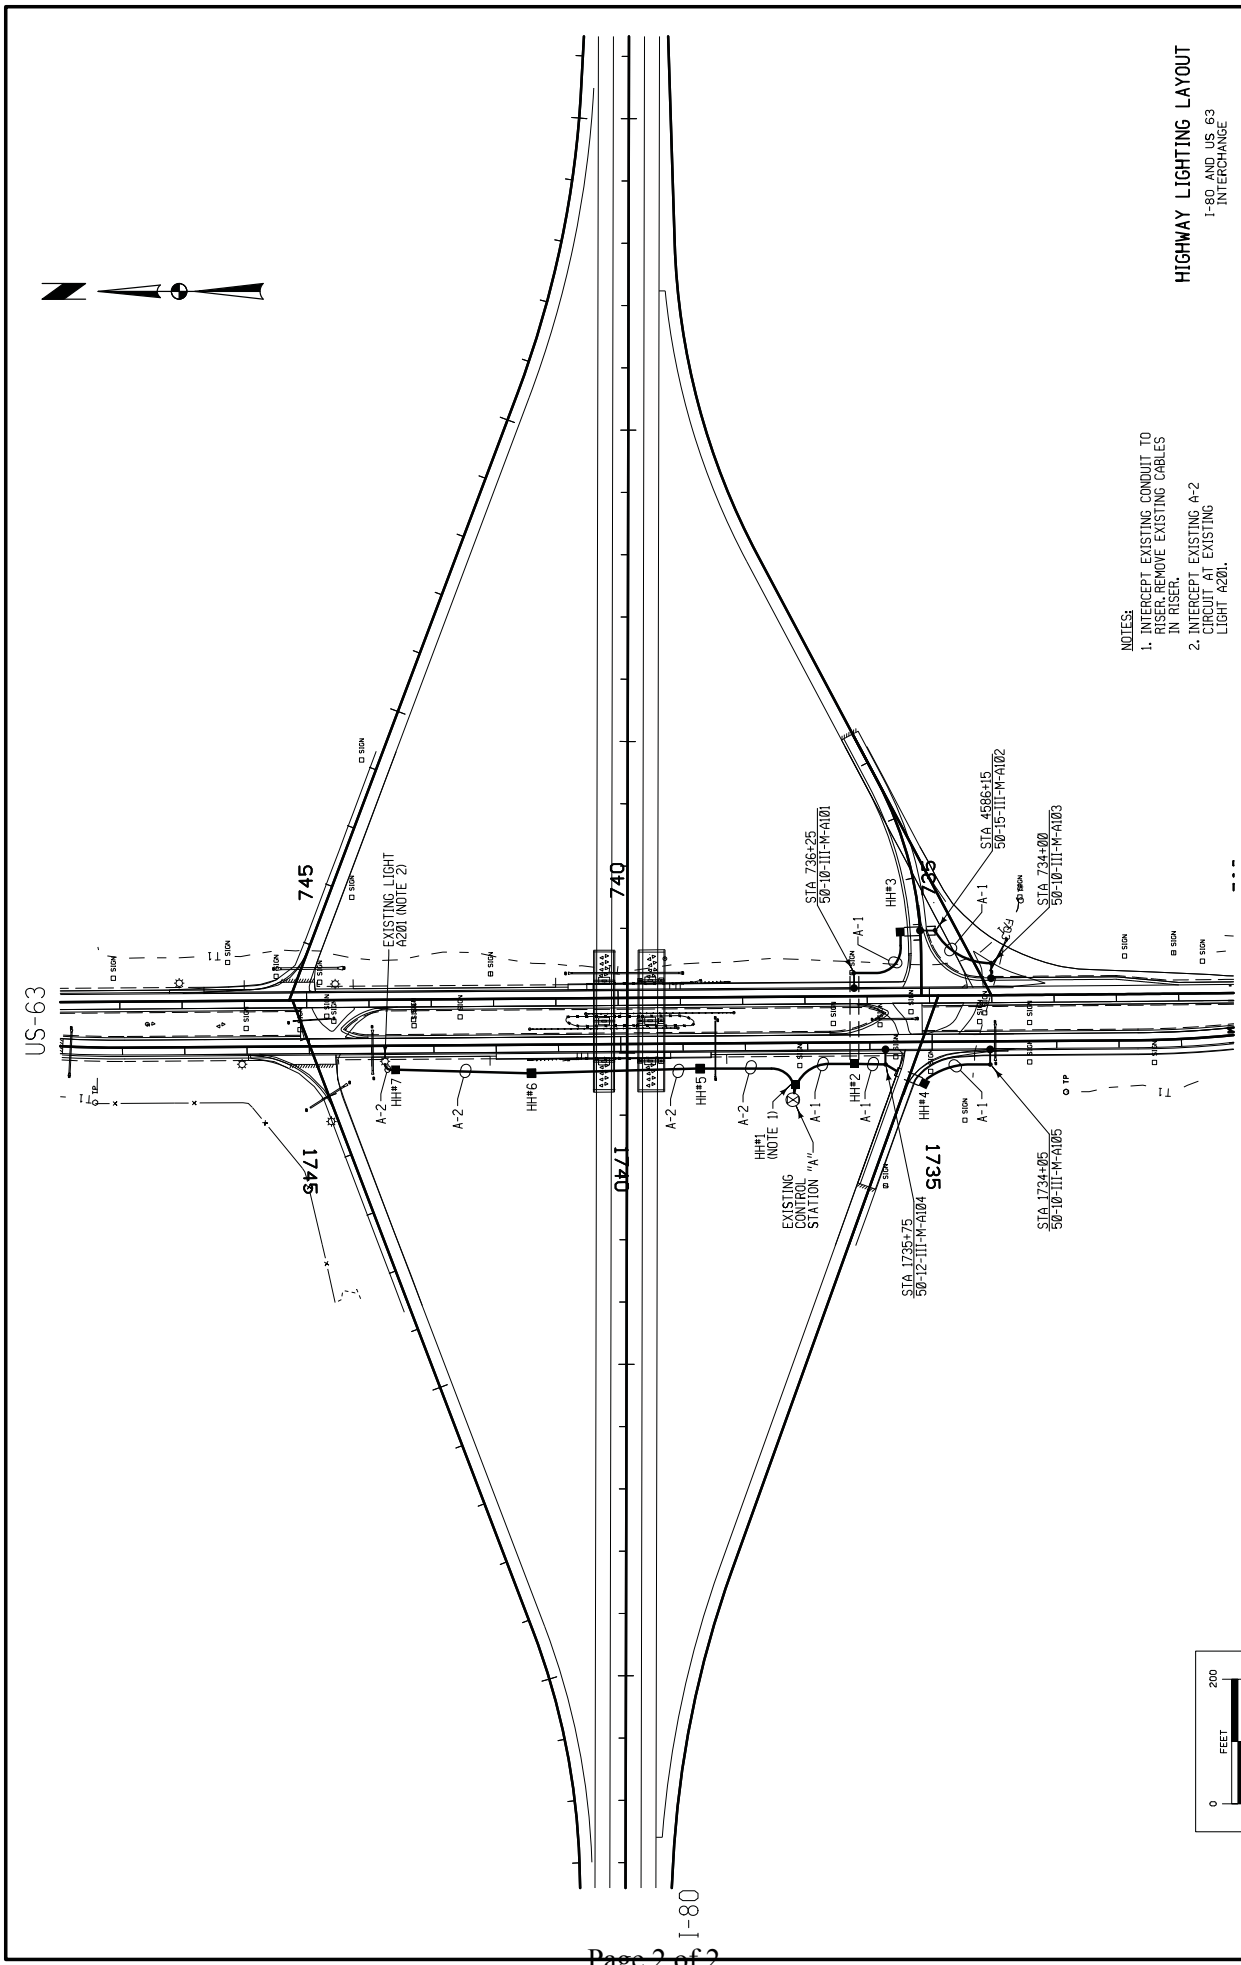

NOTES:
 1. INTERCEPT EXISTING CONDUIT TO RISER, REMOVE EXISTING CABLES IN RISER.
 2. INTERCEPT EXISTING A-2 CIRCUIT AT EXISTING LIGHT A201.

 HIGHWAY LIGHTING LAYOUT
 I-80 AND US 63 INTERCHANGE
 REVISED: 11-JUN-2015



FILE NO. 1:46:21 PM 6/7/11/2015	ENGLISH 6179	DESIGN TEAM JORGENSEN STANLEY CONSULTANTS	PROJECT NUMBER NHSN-063-4(50)-2R-79	SHEET NUMBER P.1
JORGENSEN STANLEY CONSULTANTS			REVISED: 11-JUN-2015	